
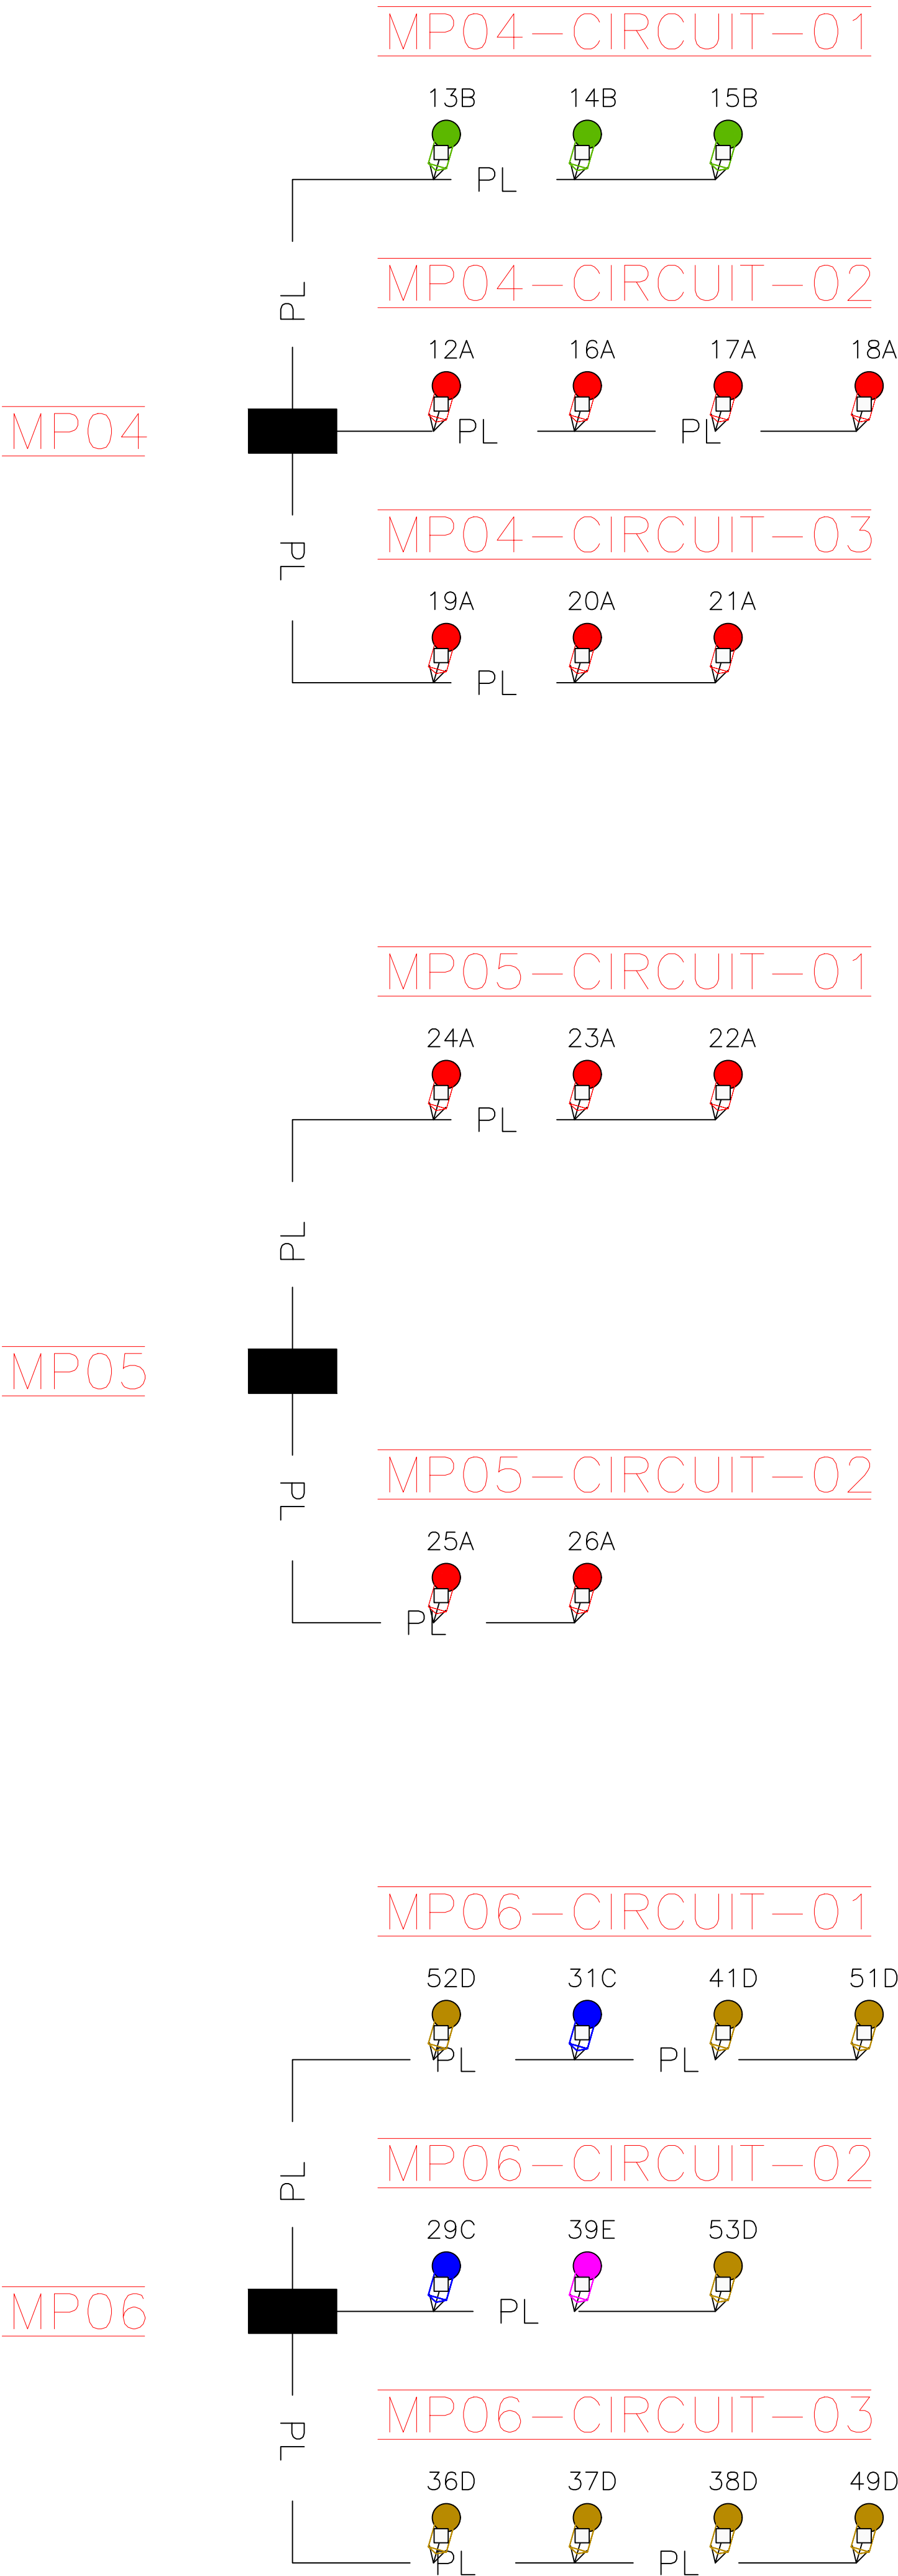


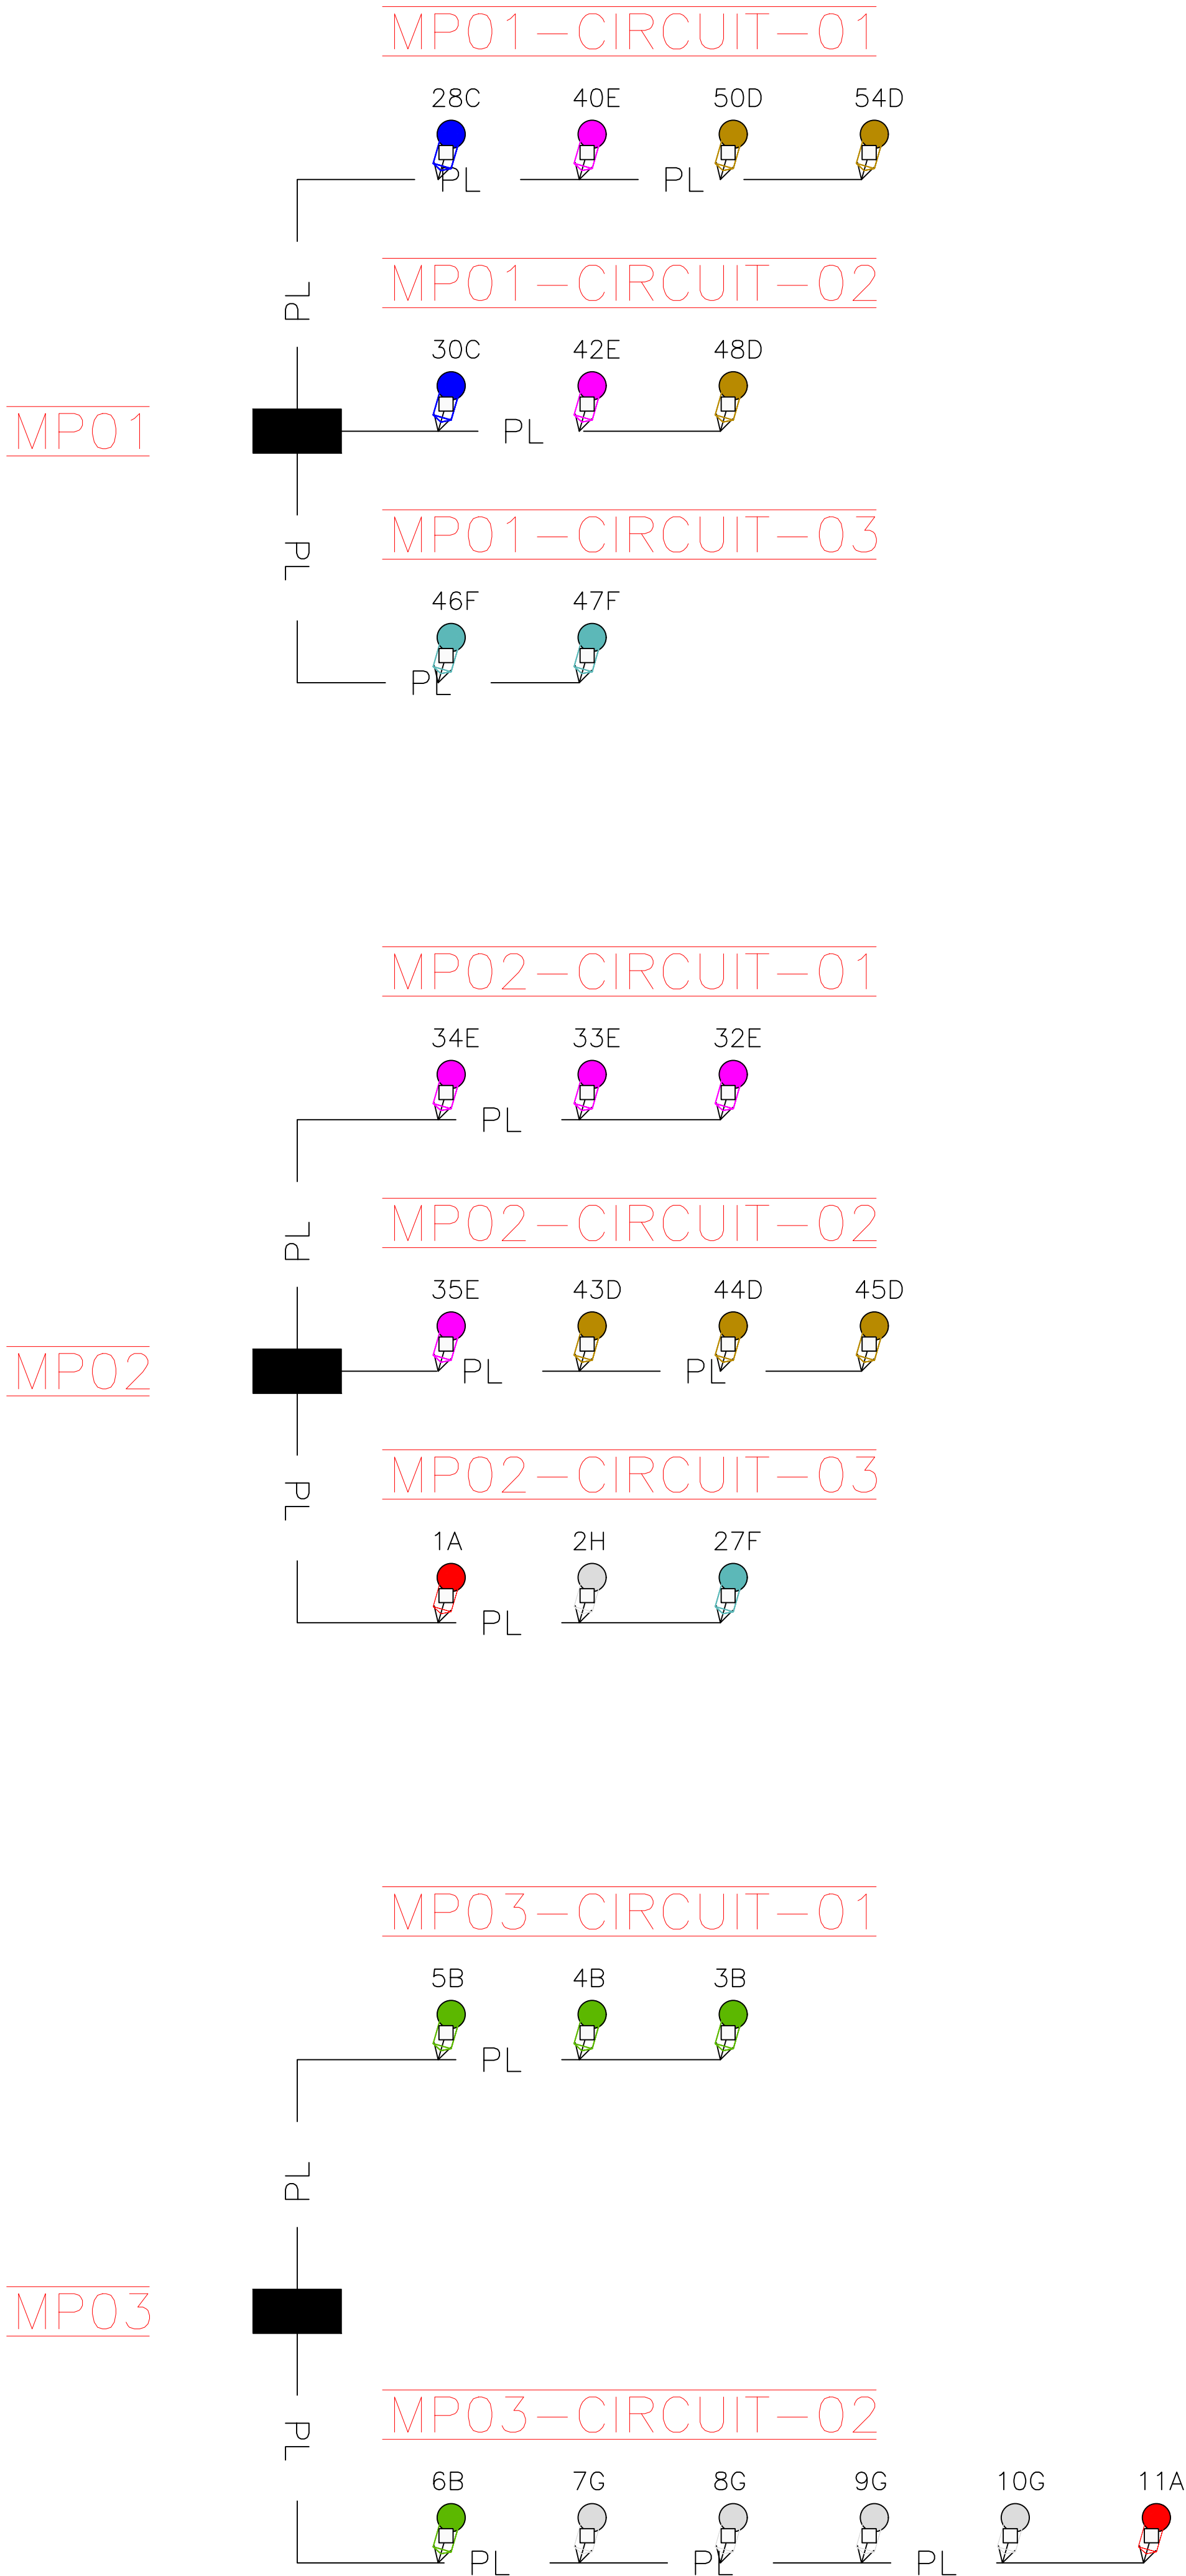

NOTES:

ANY DISCREPANCIES OR OMISSIONS TO BE REPORTED TO MORLEY WALSH CONSULTING ENGINEERS IMMEDIATELY.

DO NOT SCALE - WORK FROM FIGURED DIMENSIONS ONLY.

THIS DRAWING TO BE READ IN CONJUNCTION WITH ALL CIVIL ENGINEERS, STRUCTURAL ENGINEERS, ARCHITECTS & ALL OTHER RELEVANT DRAWINGS & SPECIFICATIONS RELATING TO THE PROJECT.

ALL DIMENSIONS TO BE CONFIRMED ON SITE.

THIS DRAWING IS THE PROPERTY OF MORLEY WALSH CONSULTING ENGINEERS AND IT OR ITS CONTENTS CANNOT BE COPIED, REPRODUCED OR OTHERWISE USED WITHOUT THE PERMISSION & CONSENT OF MORLEY WALSH CONSULTING ENGINEERS. ©

PUBLIC LIGHTING NOTES:

- CONTRACTOR TO PROVIDE 1 NO. 50mm ESB DUCT TO EACH MICRO PILLAR FROM NEAREST MINIPILLAR
- COMPLETE PUBLIC LIGHTING INSTALLATION TO BE IN ACCORDANCE WITH LOCAL COUNTY COUNCIL PUBLIC LIGHTING SPECIFICATION
- DUCTS TO BE INSTALLED 600mm BELOW GROUND LEVEL WITH MARKER TAPE LAID AT MINIMUM 300mm
- 100mm MINIMUM CLEARANCE BETWEEN PL DUCTS AND OTHER SERVICE

27W LED PL FITTING ON 6M POLE

21W LED PL FITTING ON 6M POLE

92W LED PL FITTING ON 10M POLE

55W LED PL FITTING ON 10M POLE

65W LED PL FITTING ON 10M POLE

9W LED PL FITTING ON 10M POLE

25W LED PL FITTING ON 10M POLE

21W LED PL FITTING ON 10M POLE

110mm PUBLIC LIGHTING DUCT

50mm ESB DUCT TO PL MICRO PILLAR

PUBLIC LIGHTING MICRO PILLAR

PUBLIC LIGHTING ACCESS CHAMBER

MINI-PILLAR TO BE CONFIRMED BY ESB

YA

XB

XC

XD

YE

YF

YG

XH

PL

LV

AC

03	ISSUED FOR PLANNING - UPDATED REDLINE BOUNDARY	21-06-2024
02	ISSUED FOR PLANNING - UPDATED TO LATEST SITE PLAN	13-06-2024
01	ISSUED FOR PLANNING	22-03-2024
00	ISSUED FOR REVIEW & COMMENT	14-03-2024
REV NO.	DESCRIPTION	DATE

STAGE

REVIEW & COMMENT

PROJECT TITLE:

3237 - BALLYBIN ROAD LRD

CLIENT NAME:

MARSHALL YARDS DEVELOPMENT COMPANY LTD

DRAWING TITLE:

SITE - SERVICES LAYOUTS - ELECTRICAL PUBLIC LIGHTING CIRCUITS

DOCUMENT NO:

3237-MWE-XXXX-XX-DR-E01-006901

Revision:

03

INTERNAL CAD FILE NAME:

3237[6-J01

Drawn By:

M.L

Status:	Doc. Type:	Role:	Scale @ A1:	Location Code:	Rev Date:
S3	DR	E01	Scale @ A3:	XXXX	JUN 2024



MORLEYWALSH
consulting engineers

Mechanical, Electrical & Energy Consultants
Strand House,
22 - 24 Strand Street Great,
Dublin 1.

Phone: +353 1 5321578
e-mail: info@morleywalsh.com
Web: www.morleywalsh.com