


NOTES:
ANY DISCREPANCIES OR OMISSIONS TO BE REPORTED TO MORLEY WALSH CONSULTING ENGINEERS IMMEDIATELY.
DO NOT SCALE - WORK FROM FIGURED DIMENSIONS ONLY.
THIS DRAWING TO BE READ IN CONJUNCTION WITH ALL CIVIL ENGINEERS, STRUCTURAL ENGINEERS, ARCHITECTS & ALL OTHER RELEVANT DRAWINGS & SPECIFICATIONS RELATING TO THE PROJECT.
ALL DIMENSIONS TO BE CONFIRMED ON SITE.
THIS DRAWING IS THE PROPERTY OF MORLEY WALSH CONSULTING ENGINEERS AND IT OR ITS CONTENTS CANNOT BE COPIED, REPRODUCED OR OTHERWISE USED WITHOUT THE PERMISSION & CONSENT OF MORLEY WALSH CONSULTING ENGINEERS. ©

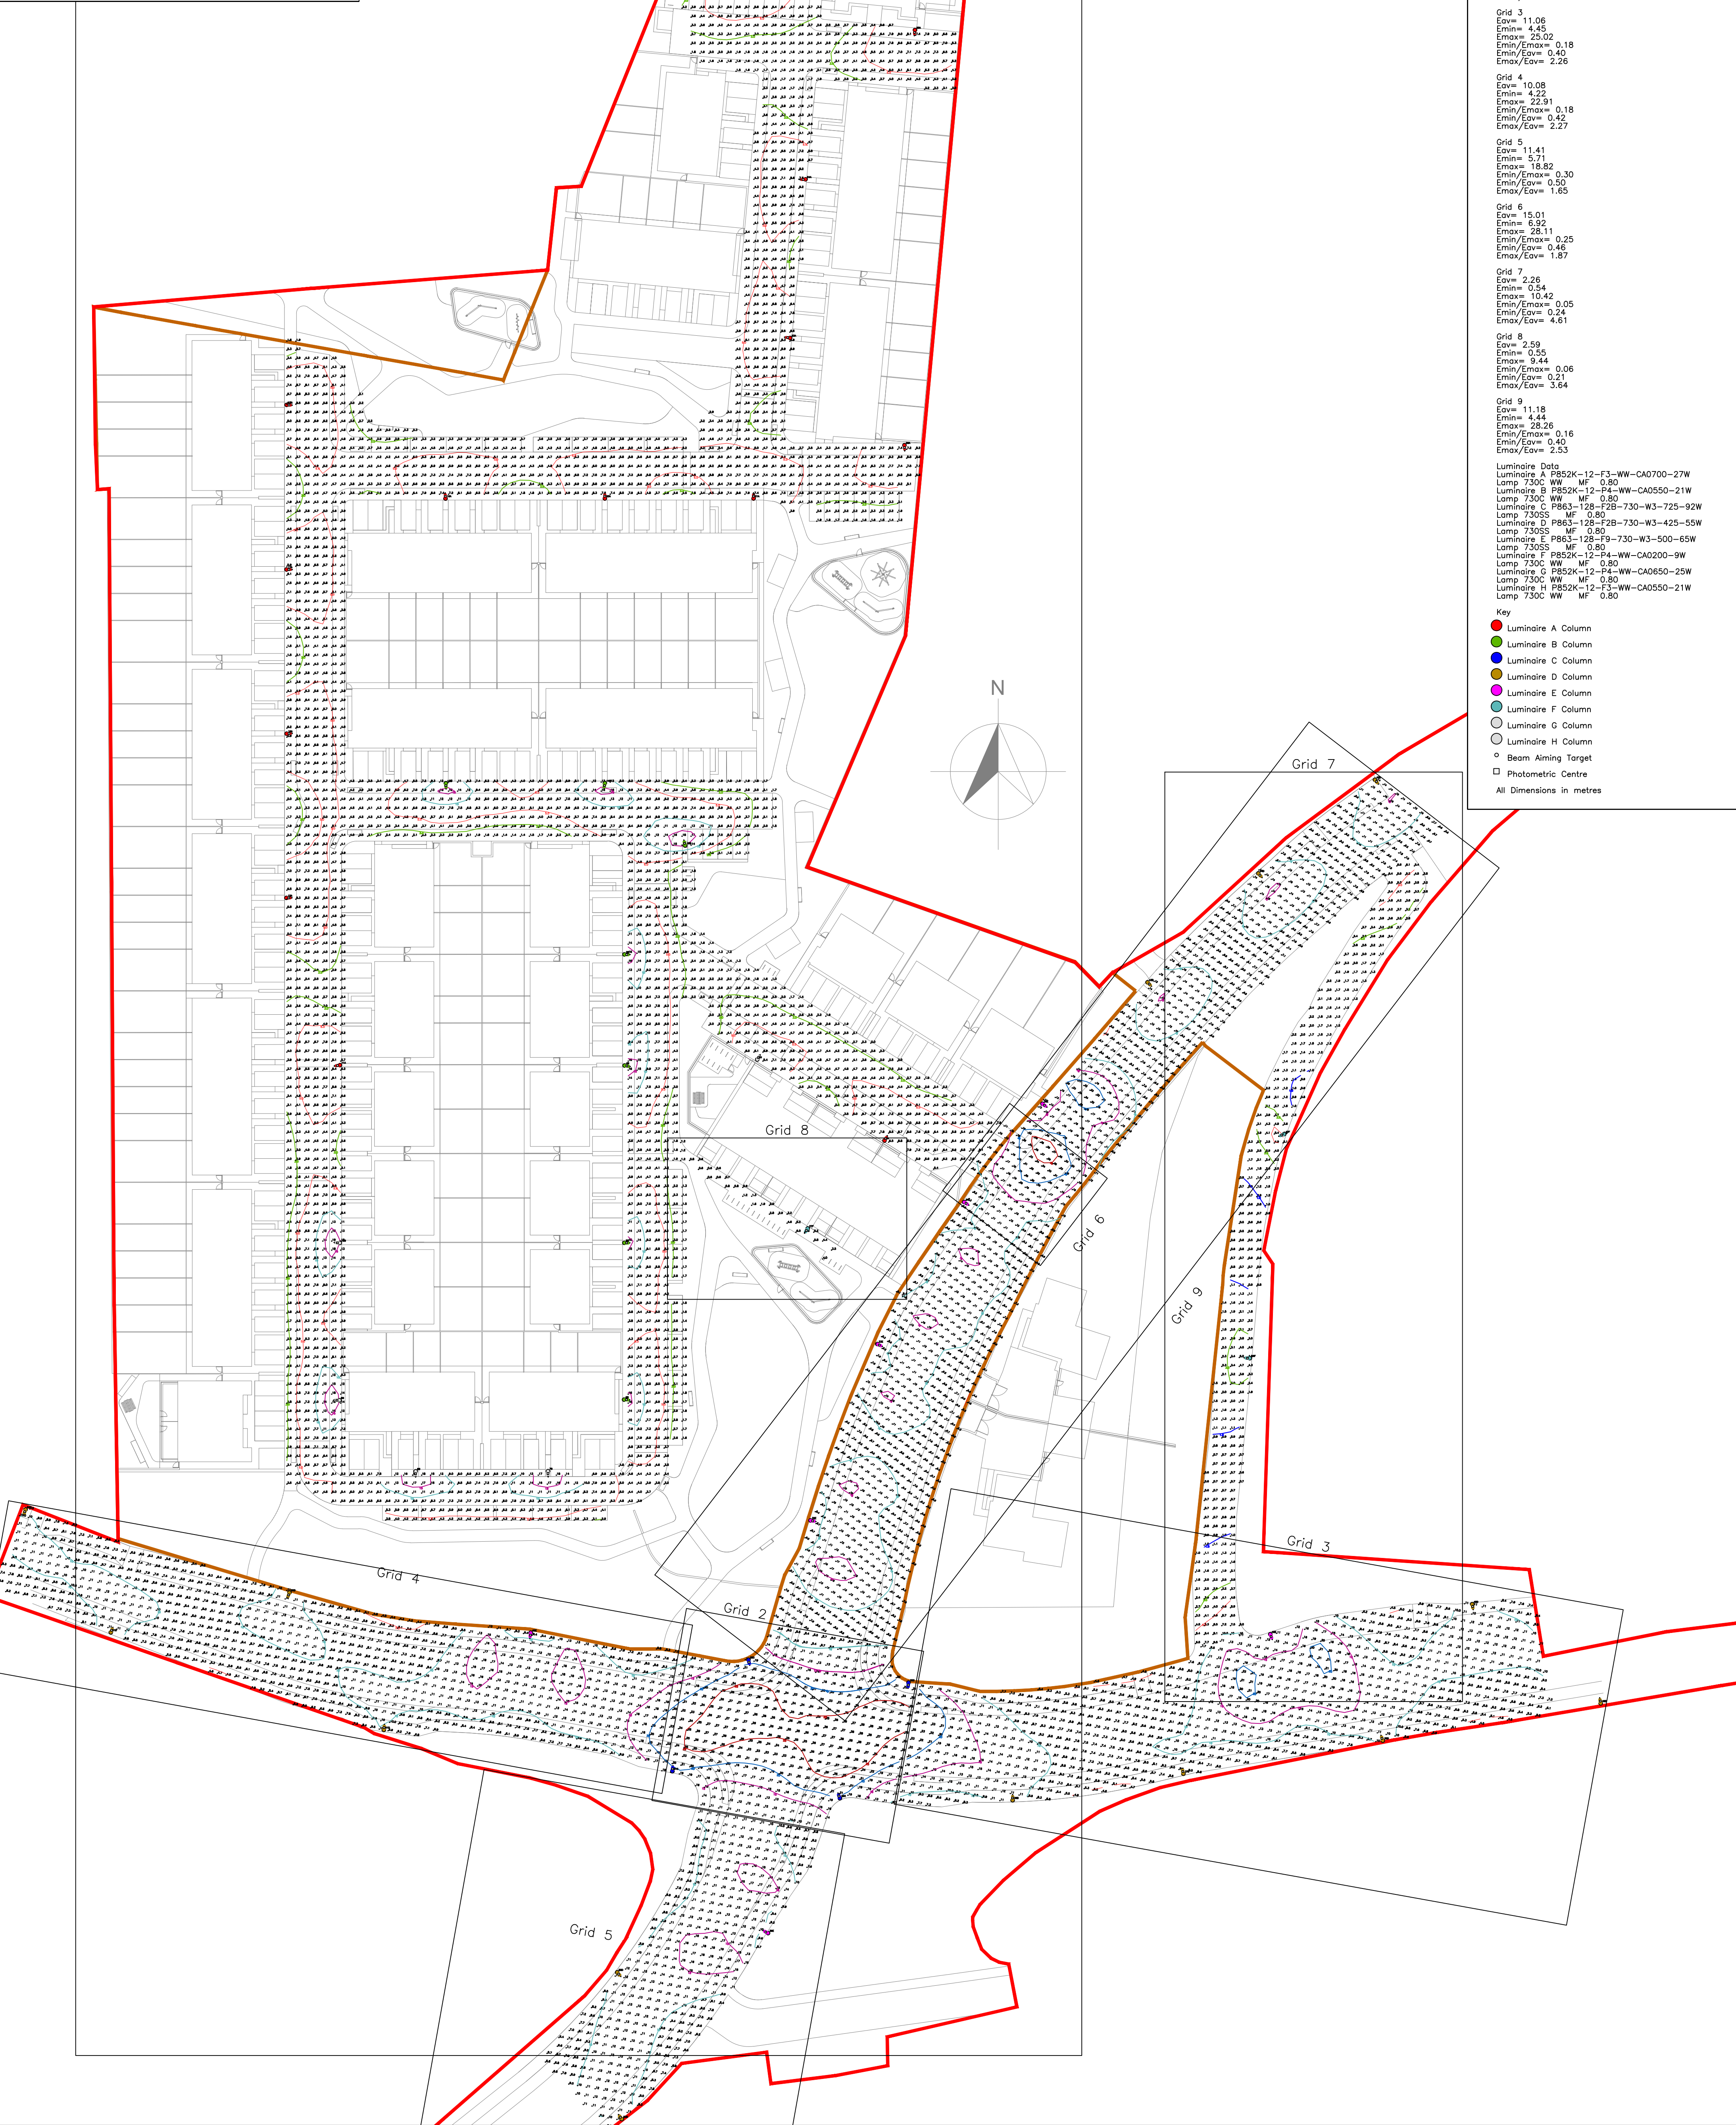

			STAGE:		DRAWING TITLE:		
			REVIEW & COMMENT		SITE SERVICES LAYOUTS PUBLIC LIGHTING		
PROJECT TITLE:			DOCUMENT NO:		Revision:		
3237 - BALLYBIN ROAD LRD			3237-MWE-XXXX-XX-DR-E01-006001		03		
CLIENT NAME:			INTERNAL CAD FILE NAME:		Drawn By:		
MARSHALL YARDS DEVELOPMENT COMPANY LTD			3237(6)-J01		M.L.		
Status:	Doc. Type:	Role:	Scale @ A1:	500	Location Code:	XXXX	Rev Date:
S3	DR	E01	Scale @ A3:	1000	Level Code:	XX	JUN 2024
			Mechanical, Electrical & Energy Consultants				
			Strand House,				
			22-24 Strand Street Great,				
			Dublin 1.				
			Phone: +353 1 5321578				
			e-mail: info@morleywalsh.com				
			Web: www.morleywalsh.com				

REV NO	DESCRIPTION	DATE
03	ISSUED FOR PLANNING - UPDATED REDLINE BOUNDARY	21-06-2024
02	ISSUED FOR PLANNING - UPDATED TO LATEST SITE PLAN	13-06-2024
01	ISSUED FOR PLANNING	22-03-2024
00	ISSUED FOR REVIEW & COMMENT	14-03-2024